


**LEGEND:**

Sl. no	Symbol	Item Description
1.		Telephone/Voice
2.		Data
3.		15 watt switch 3socket (UPS)
4.		6A/16A switch socket (Raw)
5.		Exhaust fan

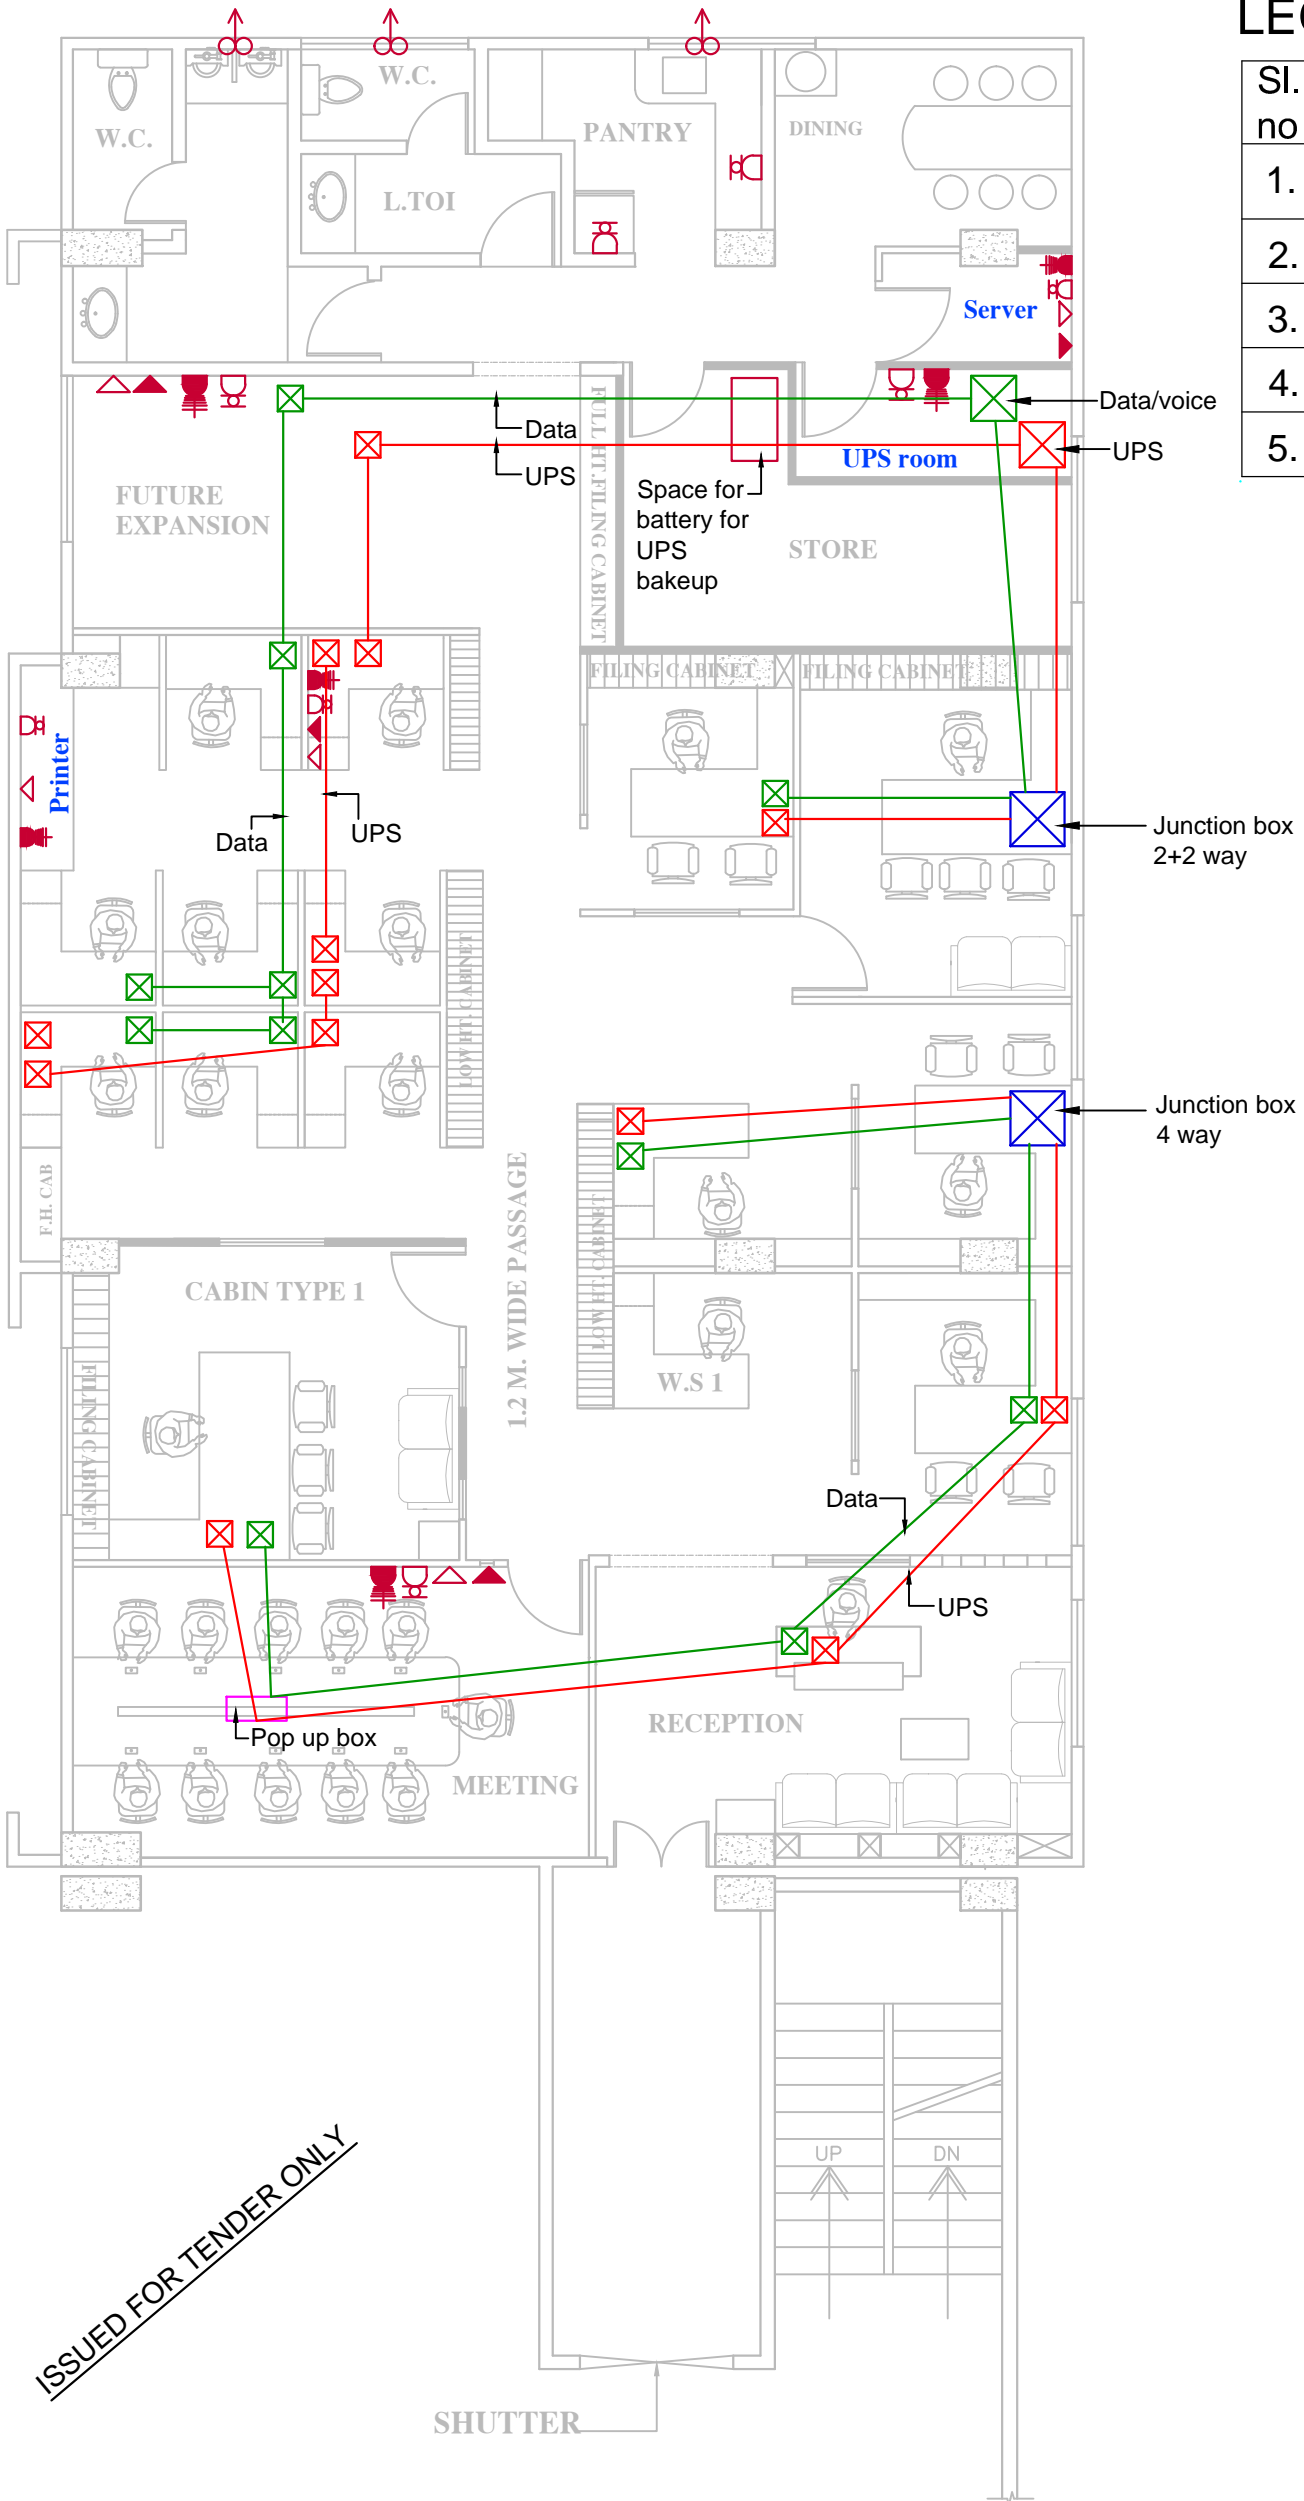

**NOTES:**

- ALL WORK STATIONS
- 1. 1 NO RAW 6/16
- 2. 1SET UPS(16A SWITCH+5PIN 6A SOCKET)

ISSUED FOR TENDER ONLY



CLIENT: SIDBI	DETAILS: POWER LAYOUT PLAN	REVISION: 00 DWG NO: SIDBI EL-01	DATE: 30.09.2016
PROJECT: INTERIOR OF SIDBI OFFICE AT GUWAHATI			

**designers' guild**  
 ARCHITECTS:INTERIORS:ENGINEERS  
 HOUSE NO-3,LANE-1,WARD STREET  
 NEAR VIVEKANANDA KENDRA  
 UZANBAZAR,GUWAHATI-781001  
 email id:contact@deguild.com  
 website:www.dguild.in